


**FLOOR PLAN - HVAC**  
SCALE: 1/4"=1'-0"

**SUPPLY AIR BRANCH DUCT SIZES**

AIRFLOW RANGE (CFM)	ROUND DUCT SIZE (IN)
UP TO 150	6
151 - 275	8
276 - 350	10
351 - 550	12
551 - 750	14

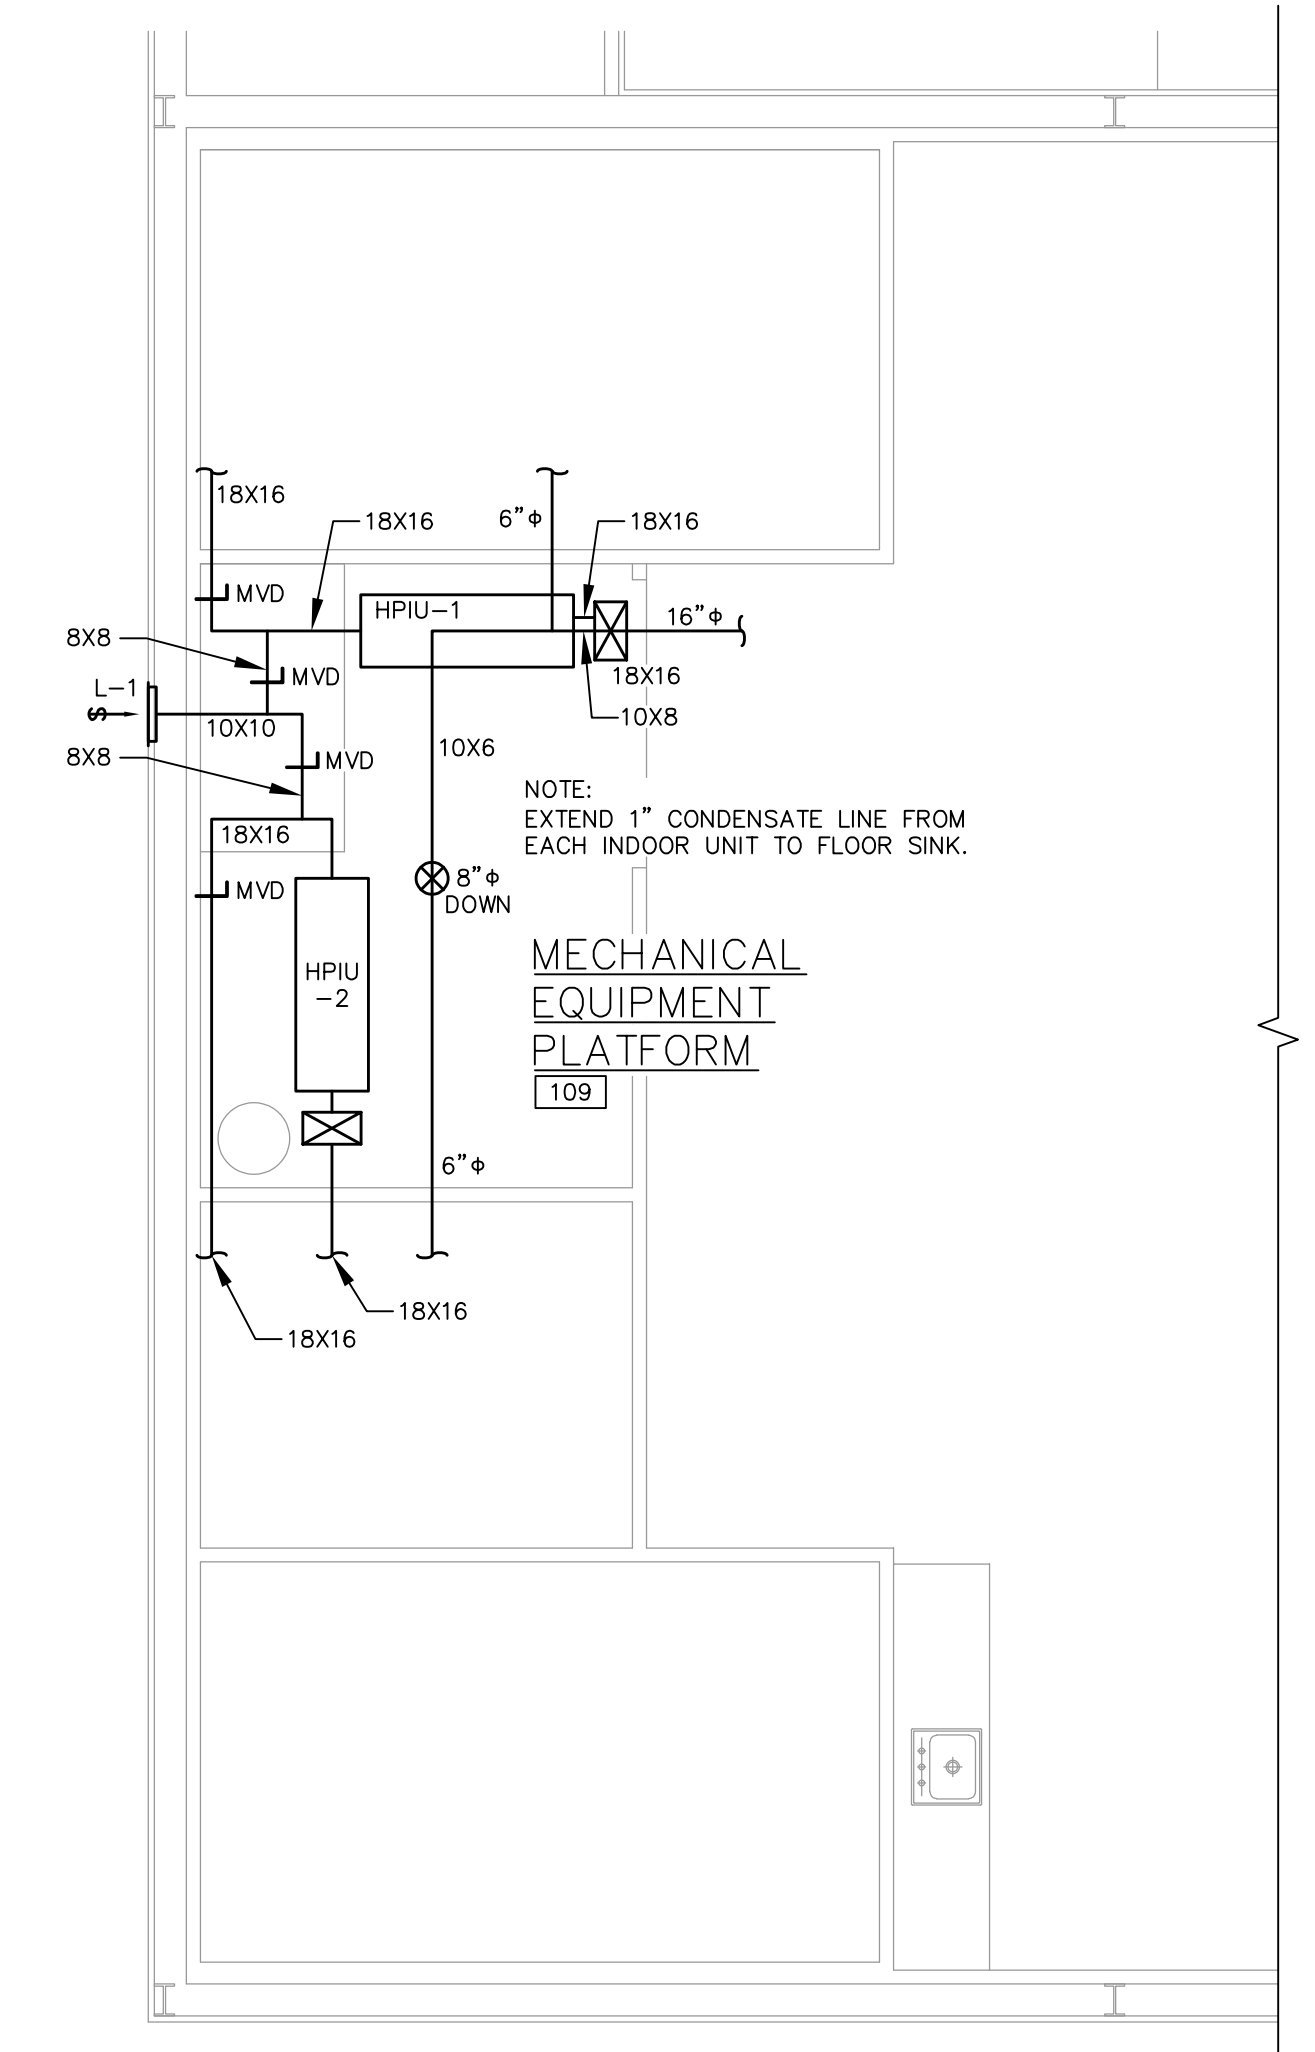

**MECHANICAL PLATFORM PLAN**  
SCALE: 1/4"=1'-0"

SE PROJECT NUMBER: 23415  
PREPARED BY:  
**SE SAMUEL ENGINEERING**  
8450 E. Crescent Parkway, Suite 200  
Greenwood Village, CO 80111  
Phone: 303.714.4840  
Fax: 303.714.4800  
TX-Registered Engineering Firm No. F13934

This document is copyrighted and is an instrument of service by Samuel Engineering (SE). It was prepared solely for the Owner's Client's use on this project only. Use, copy or disclosure of any information shown, in whole or in part, without SE's consent, is strictly prohibited, is a copyright breach and may be prosecuted. Any unauthorized reuse shall be at the sole risk of the user.

THIS DRAWING REMAINS THE PROPERTY OF THE ARCHITECT AND IS NOT TO BE USED IN ANY WAY WITHOUT HIS PERMISSION

**FRED B. PARKER • ARCHITECT**  
280 N. COLUMBIA  
STEPHENVILLE,  
TEXAS 76401  
PH. (254)965-5358  
FAX. (254)965-5393

**PARKER & ASSOCIATES**  
ARCHITECTS & PLANNERS

HVAC - FLOOR PLAN  
MULTI-PURPOSE FACILITY FOR  
RANGER COLLEGE  
609 Cooper St. Ranger Tx. 76470

DATE OF REVISIONS:  
REV 0 IFC 01/22/24

JOB NO.  
23C09RAN  
DRAWN BY:  
PL

SHEET NO.  
M-1